

NOTES:


1. FOR ADDITIONAL GENERAL NOTES, SEE DETAIL DU-01.
2. SEE DETAIL "UNPAVED AREA TRENCH (DU-02)"
 DETAIL "ASPHALT PAVED AREA TRENCH (APAT)" (DU-03) AND
 DETAIL "PROPOSED PAVEMENT AREA TRENCH (PPAT)" (DU-04)

SCALE: NTS

RECORD SIGNED COPY
 ON FILE
 APPROVED
 01-28-21
 DATE
 THE ARCHITECT/ENGINEER ASSUMES
 RESPONSIBILITY FOR THE APPROPRIATE
 USE OF THIS DETAIL.


CITY OF ROUND ROCK
JOINT TRENCH DETAIL
(ELECTRIC, TELEPHONE,
CABLE AND GAS)


DRAWING NO:
 DU-07.1
 SHEET 1 of 4

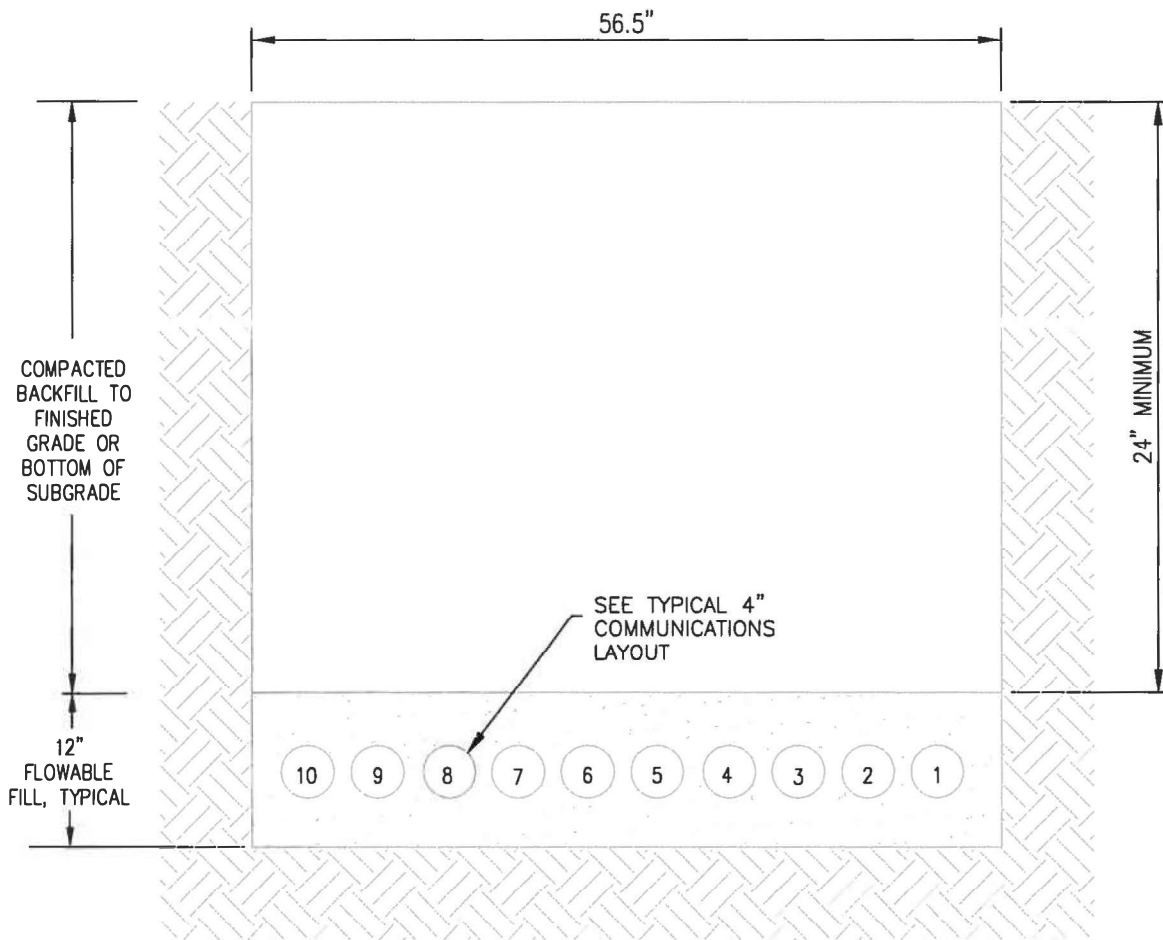
DUCT BANK LINE DETAIL
NTS

1. FOR ADDITIONAL GENERAL NOTES, SEE DETAIL DU-01.
2. SEE DETAIL "UNPAVED AREA TRENCH (DU-02)" DETAIL "ASPHALT PAVED AREA TRENCH (APAT)" (DU-03) AND DETAIL "PROPOSED PAVEMENT AREA TRENCH (PPAT)" (DU-04)

RECORD SIGNED COPY ON FILE <hr/> APPROVED <hr/> 01-28-21 DATE	CITY OF ROUND ROCK	SCALE: NTS DRAWING NO: DU-07.2 SHEET 2 of 4
THE ARCHITECT/ENGINEER ASSUMES RESPONSIBILITY FOR THE APPROPRIATE USE OF THIS DETAIL.	JOINT TRENCH DETAIL (DUCT BANK LINE)	

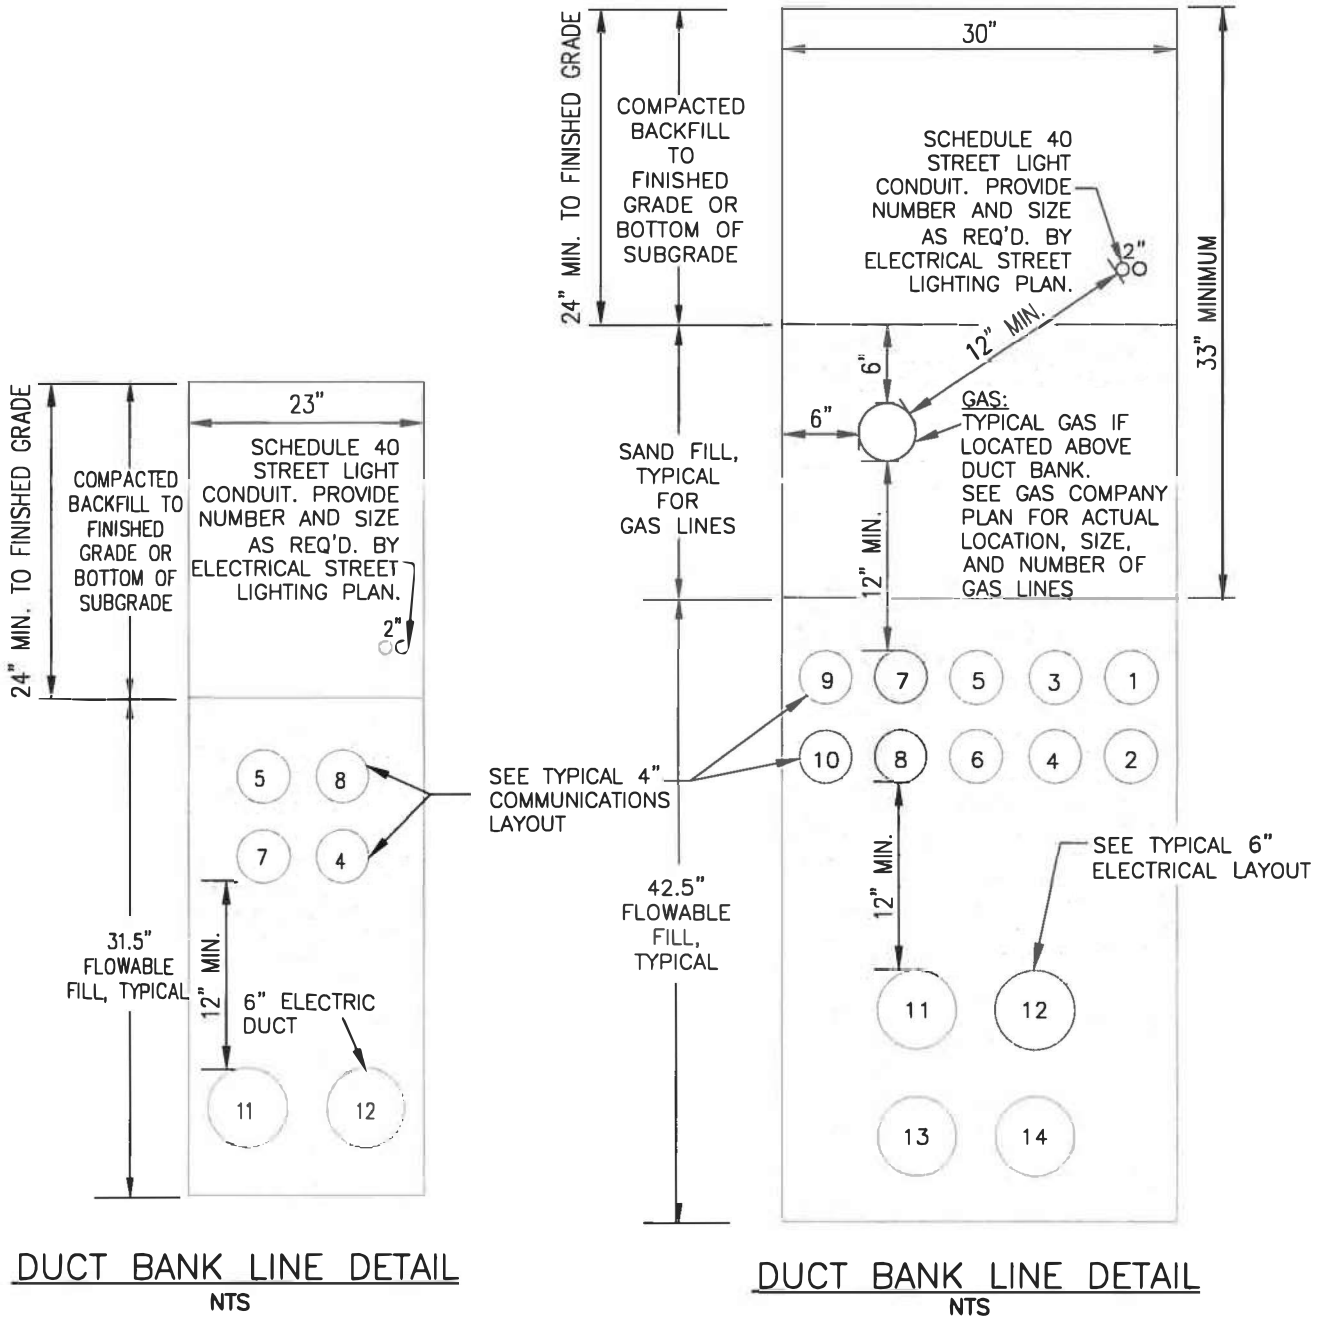


1. FOR ADDITIONAL GENERAL NOTES, SEE DETAIL DU-01.
2. SEE DETAIL "UNPAVED AREA TRENCH (DU-02)" DETAIL "ASPHALT PAVED AREA TRENCH (APAT)" (DU-03) AND DETAIL "PROPOSED PAVEMENT AREA TRENCH (PPAT)" (DU-04)

RECORD SIGNED COPY ON FILE APPROVED 01-28-21 DATE THE ARCHITECT/ENGINEER ASSUMES RESPONSIBILITY FOR THE APPROPRIATE USE OF THIS DETAIL.	<h1>CITY OF ROUND ROCK</h1> <h2>JOINT TRENCH DETAIL (DUCT BANK LINES)</h2>	SCALE: NTS DRAWING NO: DU-07.3 SHEET 3 of 4 
--	---	---

NOTE:


CONTRACTOR SHALL BE RESPONSIBLE TO COORDINATE COMMUNICATIONS, INQUIRIES, REMOVALS, RELOCATIONS, INSTALLATIONS, AND ALL TIMELY SCHEDULING, ETC., WITH EACH SPECIFIC UTILITY AND COMMUNICATE BACK TO THE CITY AND ENGINEER IN ORDER FOR THE CONTRACTOR TO INDEPENDENTLY PURSUE THE WORK WITHOUT DELAYS.

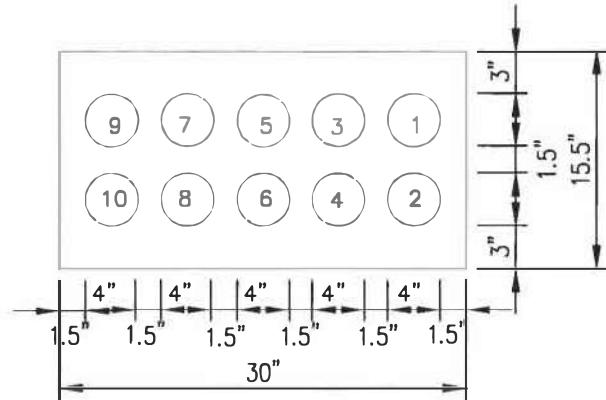

TYPICAL 4" COMMUNICATIONS LAYOUT
NTS

4" DIAMETER COMMUNICATION DUCT ALLOCATIONS

1. AT&T
2. AT&T
3. AT&T
4. AT&T
5. SPECTRUM CABLE
6. LEVEL 3
7. CITY OF ROUND ROCK
8. CITY OF ROUND ROCK
9. CITY OF ROUND ROCK
10. CITY OF ROUND ROCK

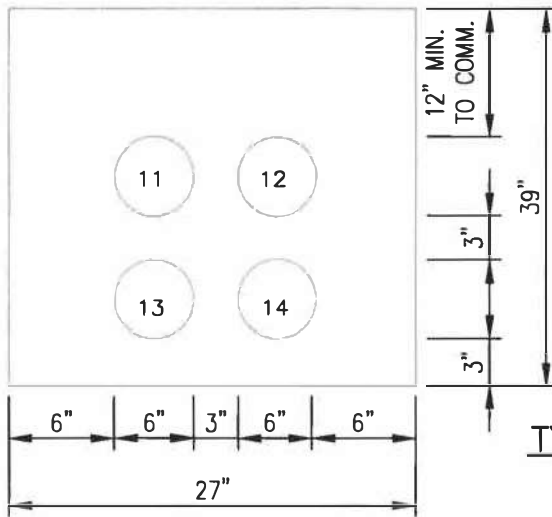

TYPICAL 6" ELECTRICAL LAYOUT
NTS


6" DIAMETER ELECTRIC DUCT ALLOCATIONS FOR ONCOR

11. 6" ONCOR
12. 6" ONCOR
13. 6" ONCOR
14. 6" ONCOR

TYPICAL DUCT BANK CONDUIT ALLOCATIONS

1. FOR ADDITIONAL GENERAL NOTES, SEE DETAIL DU-01.
2. SEE DETAIL "UNPAVED AREA TRENCH (DU-02)" DETAIL "ASPHALT PAVED AREA TRENCH (APAT)" (DU-03) AND DETAIL "PROPOSED PAVEMENT AREA TRENCH (PPAT)" (DU-04)

SCALE: NTS

RECORD SIGNED COPY ON FILE APPROVED 01-28-21 DATE THE ARCHITECT/ENGINEER ASSUMES RESPONSIBILITY FOR THE APPROPRIATE USE OF THIS DETAIL.	CITY OF ROUND ROCK JOINT TRENCH DETAIL (TYPICAL COMMUNICATION & ELECTRICAL DUCT ALLOCATIONS)	DRAWING NO: DU-07.4 SHEET 4 of 4 
--	--	---